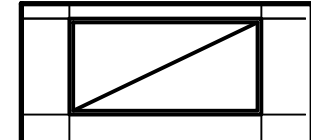
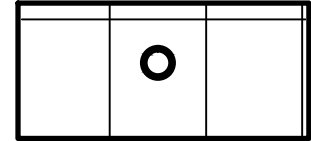
 
 
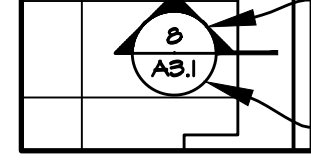
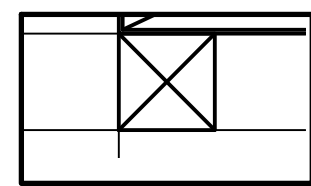
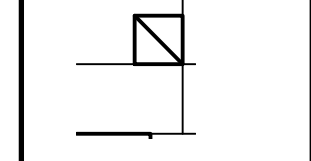





NOTES

1. LIGHT FIXTURES, MECHANICAL DIFFUSERS & GRILLS ARE SHOWN FOR COORDINATION. REFER TO THE MECHANICAL & ELECTRICAL DRAWINGS.
2. SCRIBE THE CEILING GRID TO THE WALL FOR A TIGHT FIT.
3. CEILING HEIGHTS ARE 9'-0" THROUGHOUT.

LEGEND


-  ACOUSTICAL PANEL CEILING WITH 2"x4" FLUORESCENT LIGHT RE: ELECTRICAL
-  ACOUSTICAL PANEL CEILING WITH DOWN LIGHT RE: ELECTRICAL
-  ROOM NUMBER
-  GYPSUM BOARD CEILING.
-  DETAIL REFERENCE
DRAWING NUMBER
SHEET NUMBER
-  SUPPLY AIR DIFFUSER, RE: MECHANICAL
-  RETURN AIR DIFFUSER, RE: MECHANICAL

KEY PLAN

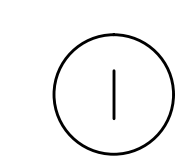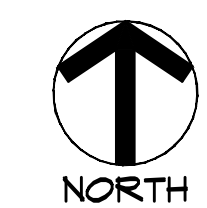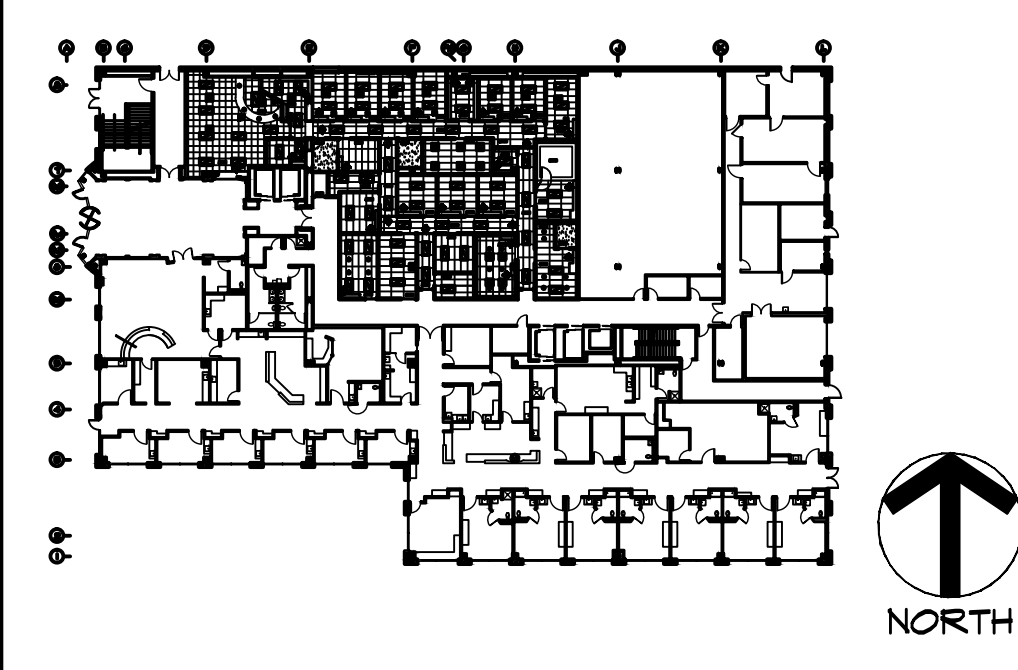

1ST FLOOR PLAN

 NEW REFLECTED CEILING PLAN 1/8" = 1'-0"



Andrews ARCHITECTURE LLC
 STANLEY R. ANDREWS AIA NCARB
 322 SOUTH HUMBOLDT
 DENVER, COLORADO 80209
 standrews@comcast.net 303.778.6801 OFFICE

**THE CHILDREN'S HOSPITAL
 AT SAINT JOSEPH HOSPITAL
 SPECIALTY CLINICS**
 1835 FRANKLIN STREET
 DENVER, COLORADO 80218



DRAWING CONTENTS:
REFLECTED CEILING PLAN

ISSUED FOR:
 CONSTRUCTION DOCUMENTS
 DATE: FEBRUARY 14, 2010
 REVISIONS:

SHEET NO.
A2.2

1. 2010 - ALL DRAWINGS PROVIDED BY ANDREWS ARCHITECTURE LLC AND THEIR CONSULTANTS, BOTH HARD COPY AND ELECTRONIC MEDIA, ARE INSTRUMENTS OF SERVICE AND NOT TO BE REPRODUCED, DISSEMINATED, OR REPRODUCED WITHOUT WRITTEN CONSENT.